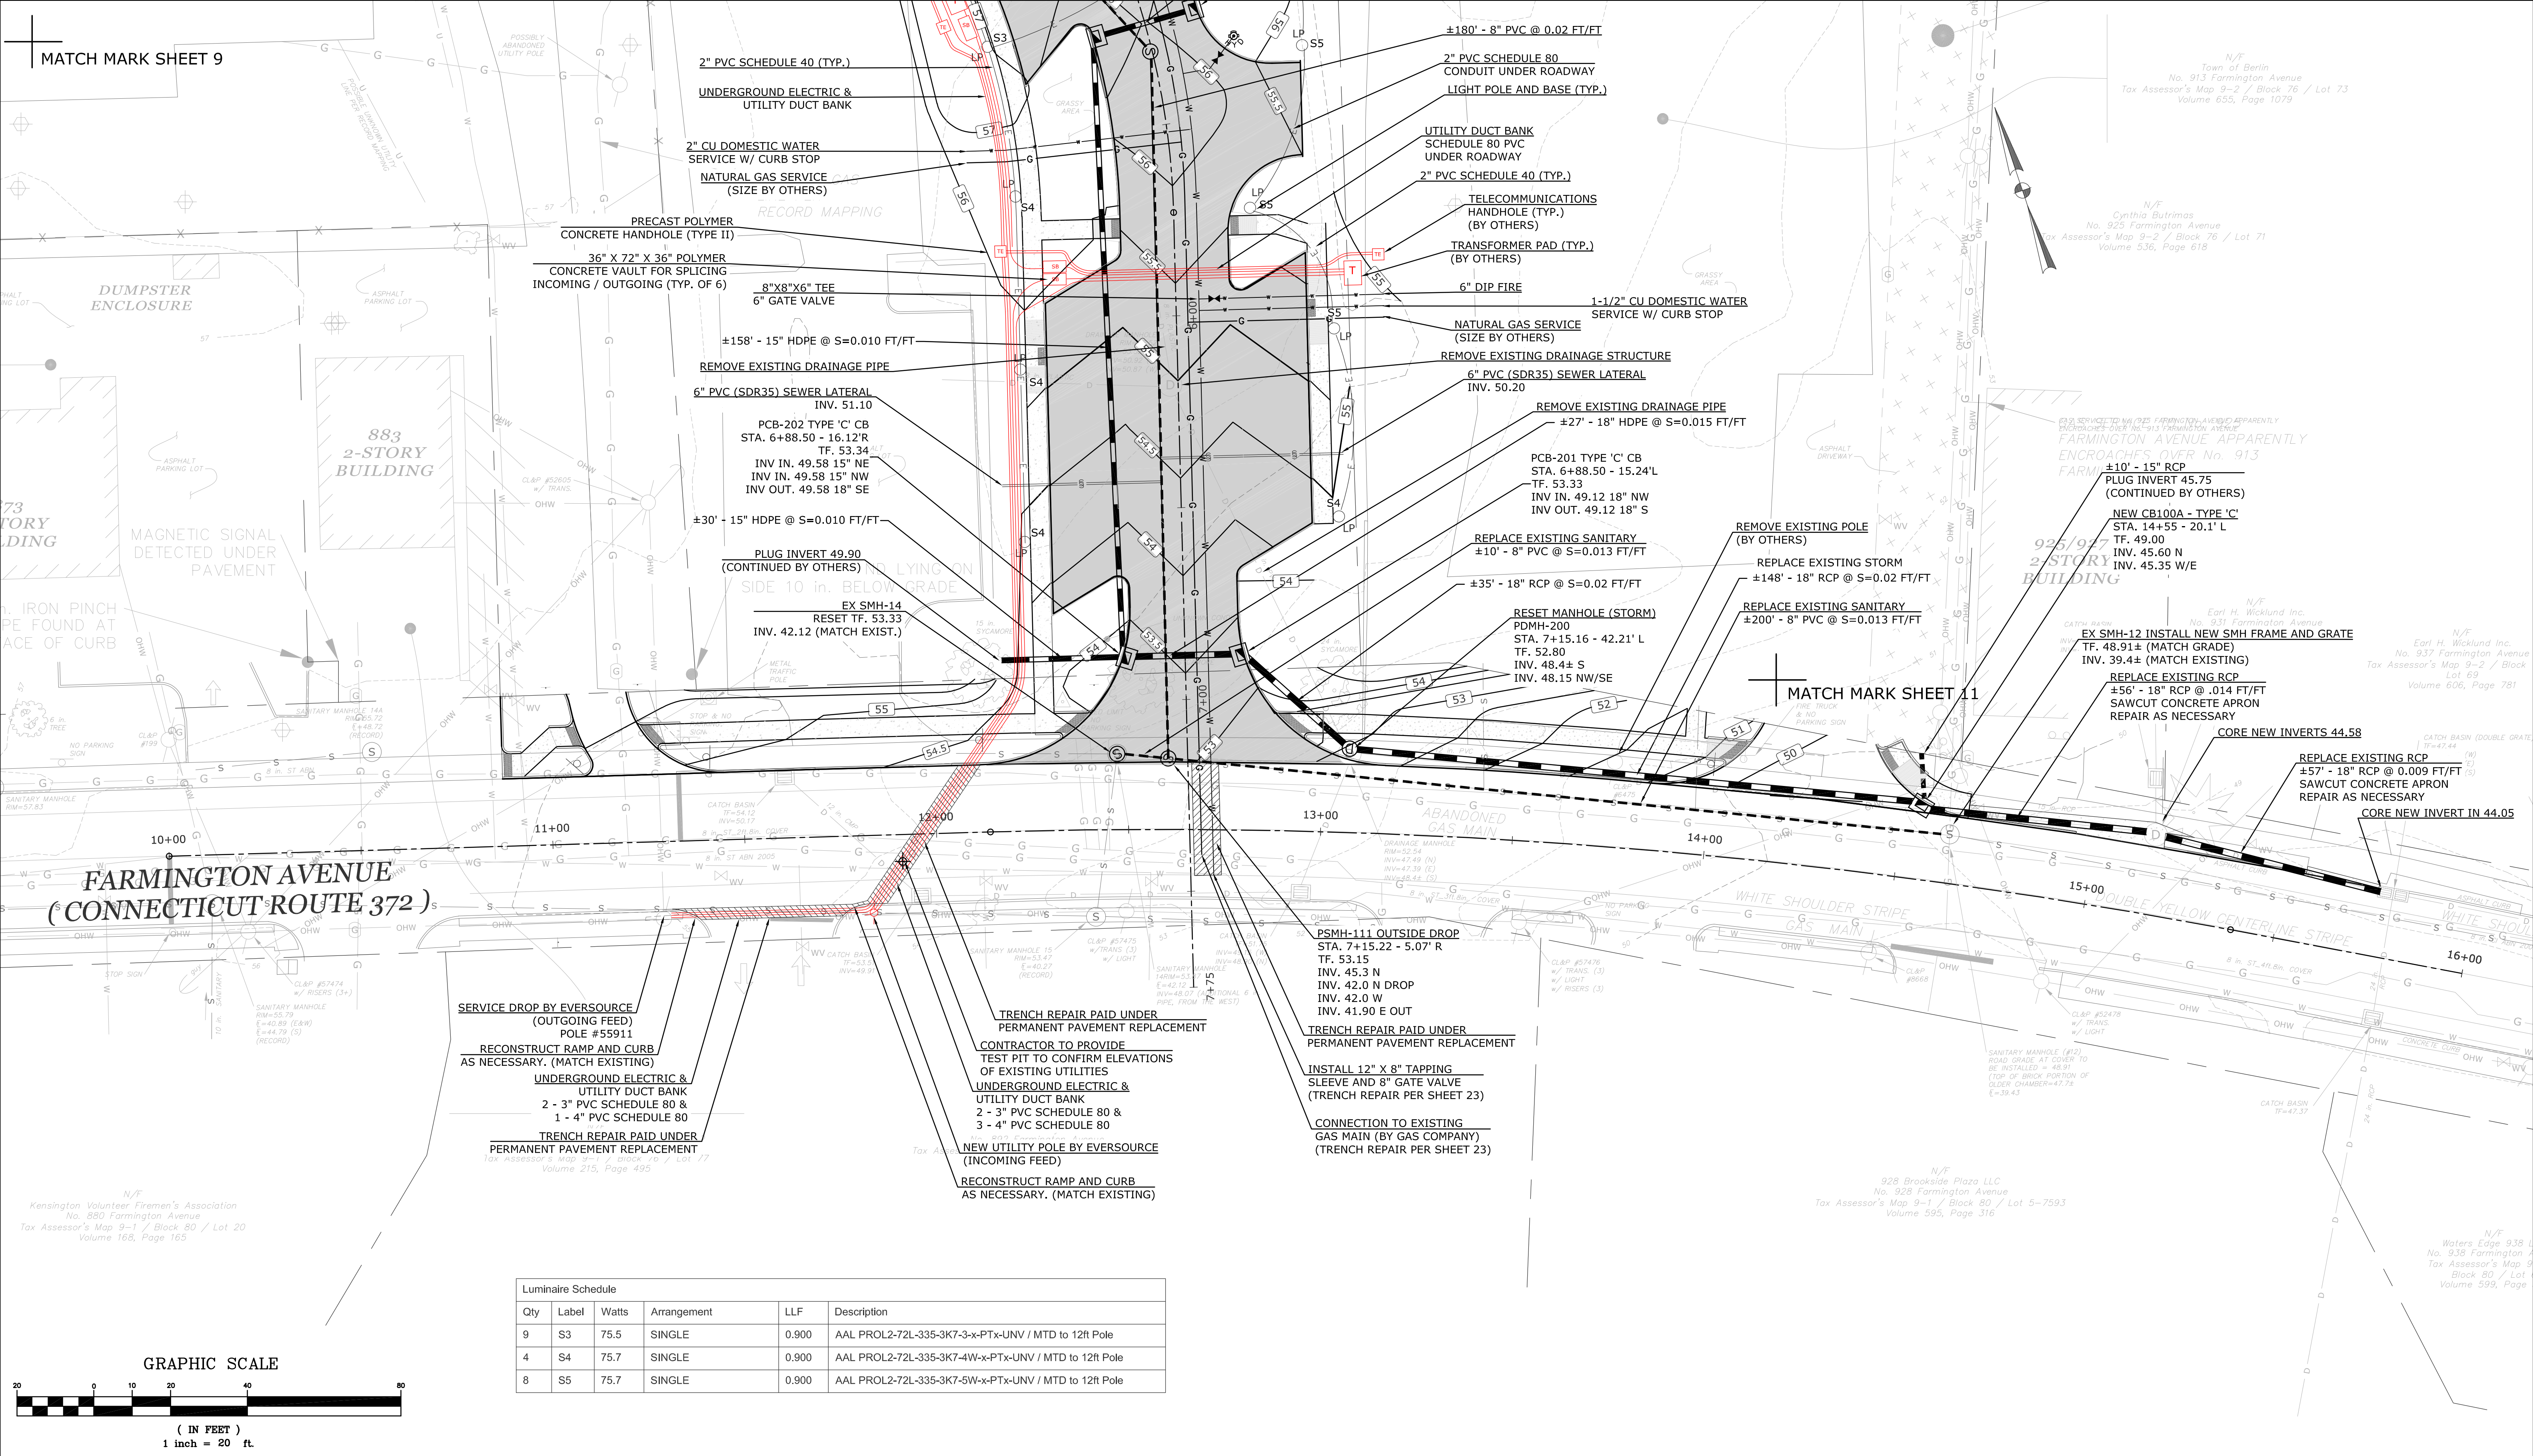


Luminaire Schedule					
Qty	Label	Watts	Arrangement	LLF	Description
9	S3	75.5	SINGLE	0.900	AAL PROL2-72L-335-3K7-3-x-PTx-UNV / MTD to 12ft Pole
4	S4	75.7	SINGLE	0.900	AAL PROL2-72L-335-3K7-4W-x-PTx-UNV / MTD to 12ft Pole
8	S5	75.7	SINGLE	0.900	AAL PROL2-72L-335-3K7-5W-x-PTx-UNV / MTD to 12ft Pole

NO.	DATE	DESCRIPTION
REVISIONS		
1	06/26/20	ADD SPLICE BOXES PER EVERSOURCE

SUPV.	S.R.M.
DESIGN	R.E.B.
DRAWN	R.E.B.
CHECKED	S.R.M.
DATE	06/02/20

SCALE
1" = 40'

WMC
CONSULTING ENGINEERS

• WENGELL, McDONNELL & COSTELLO •
87 HOLMES ROAD
NEWINGTON, CT 06111
(860) 667-9624

PREPARED FOR

TOWN OF BERLIN
240 KENSINGTON ROAD
BERLIN, CT 06037

**UTILITY PLAN
BOULEVARD TO THE TRAIN STATION
BERLIN, CONNECTICUT**

D - BERLIN_BLVDPD		BERLIN_BLVDPD	14083.10	—	SHEET 10
SIZE	PROJECT	FILE NAME	NUMBER	REV.	
				OF	33